


— New  
 - - - Existing

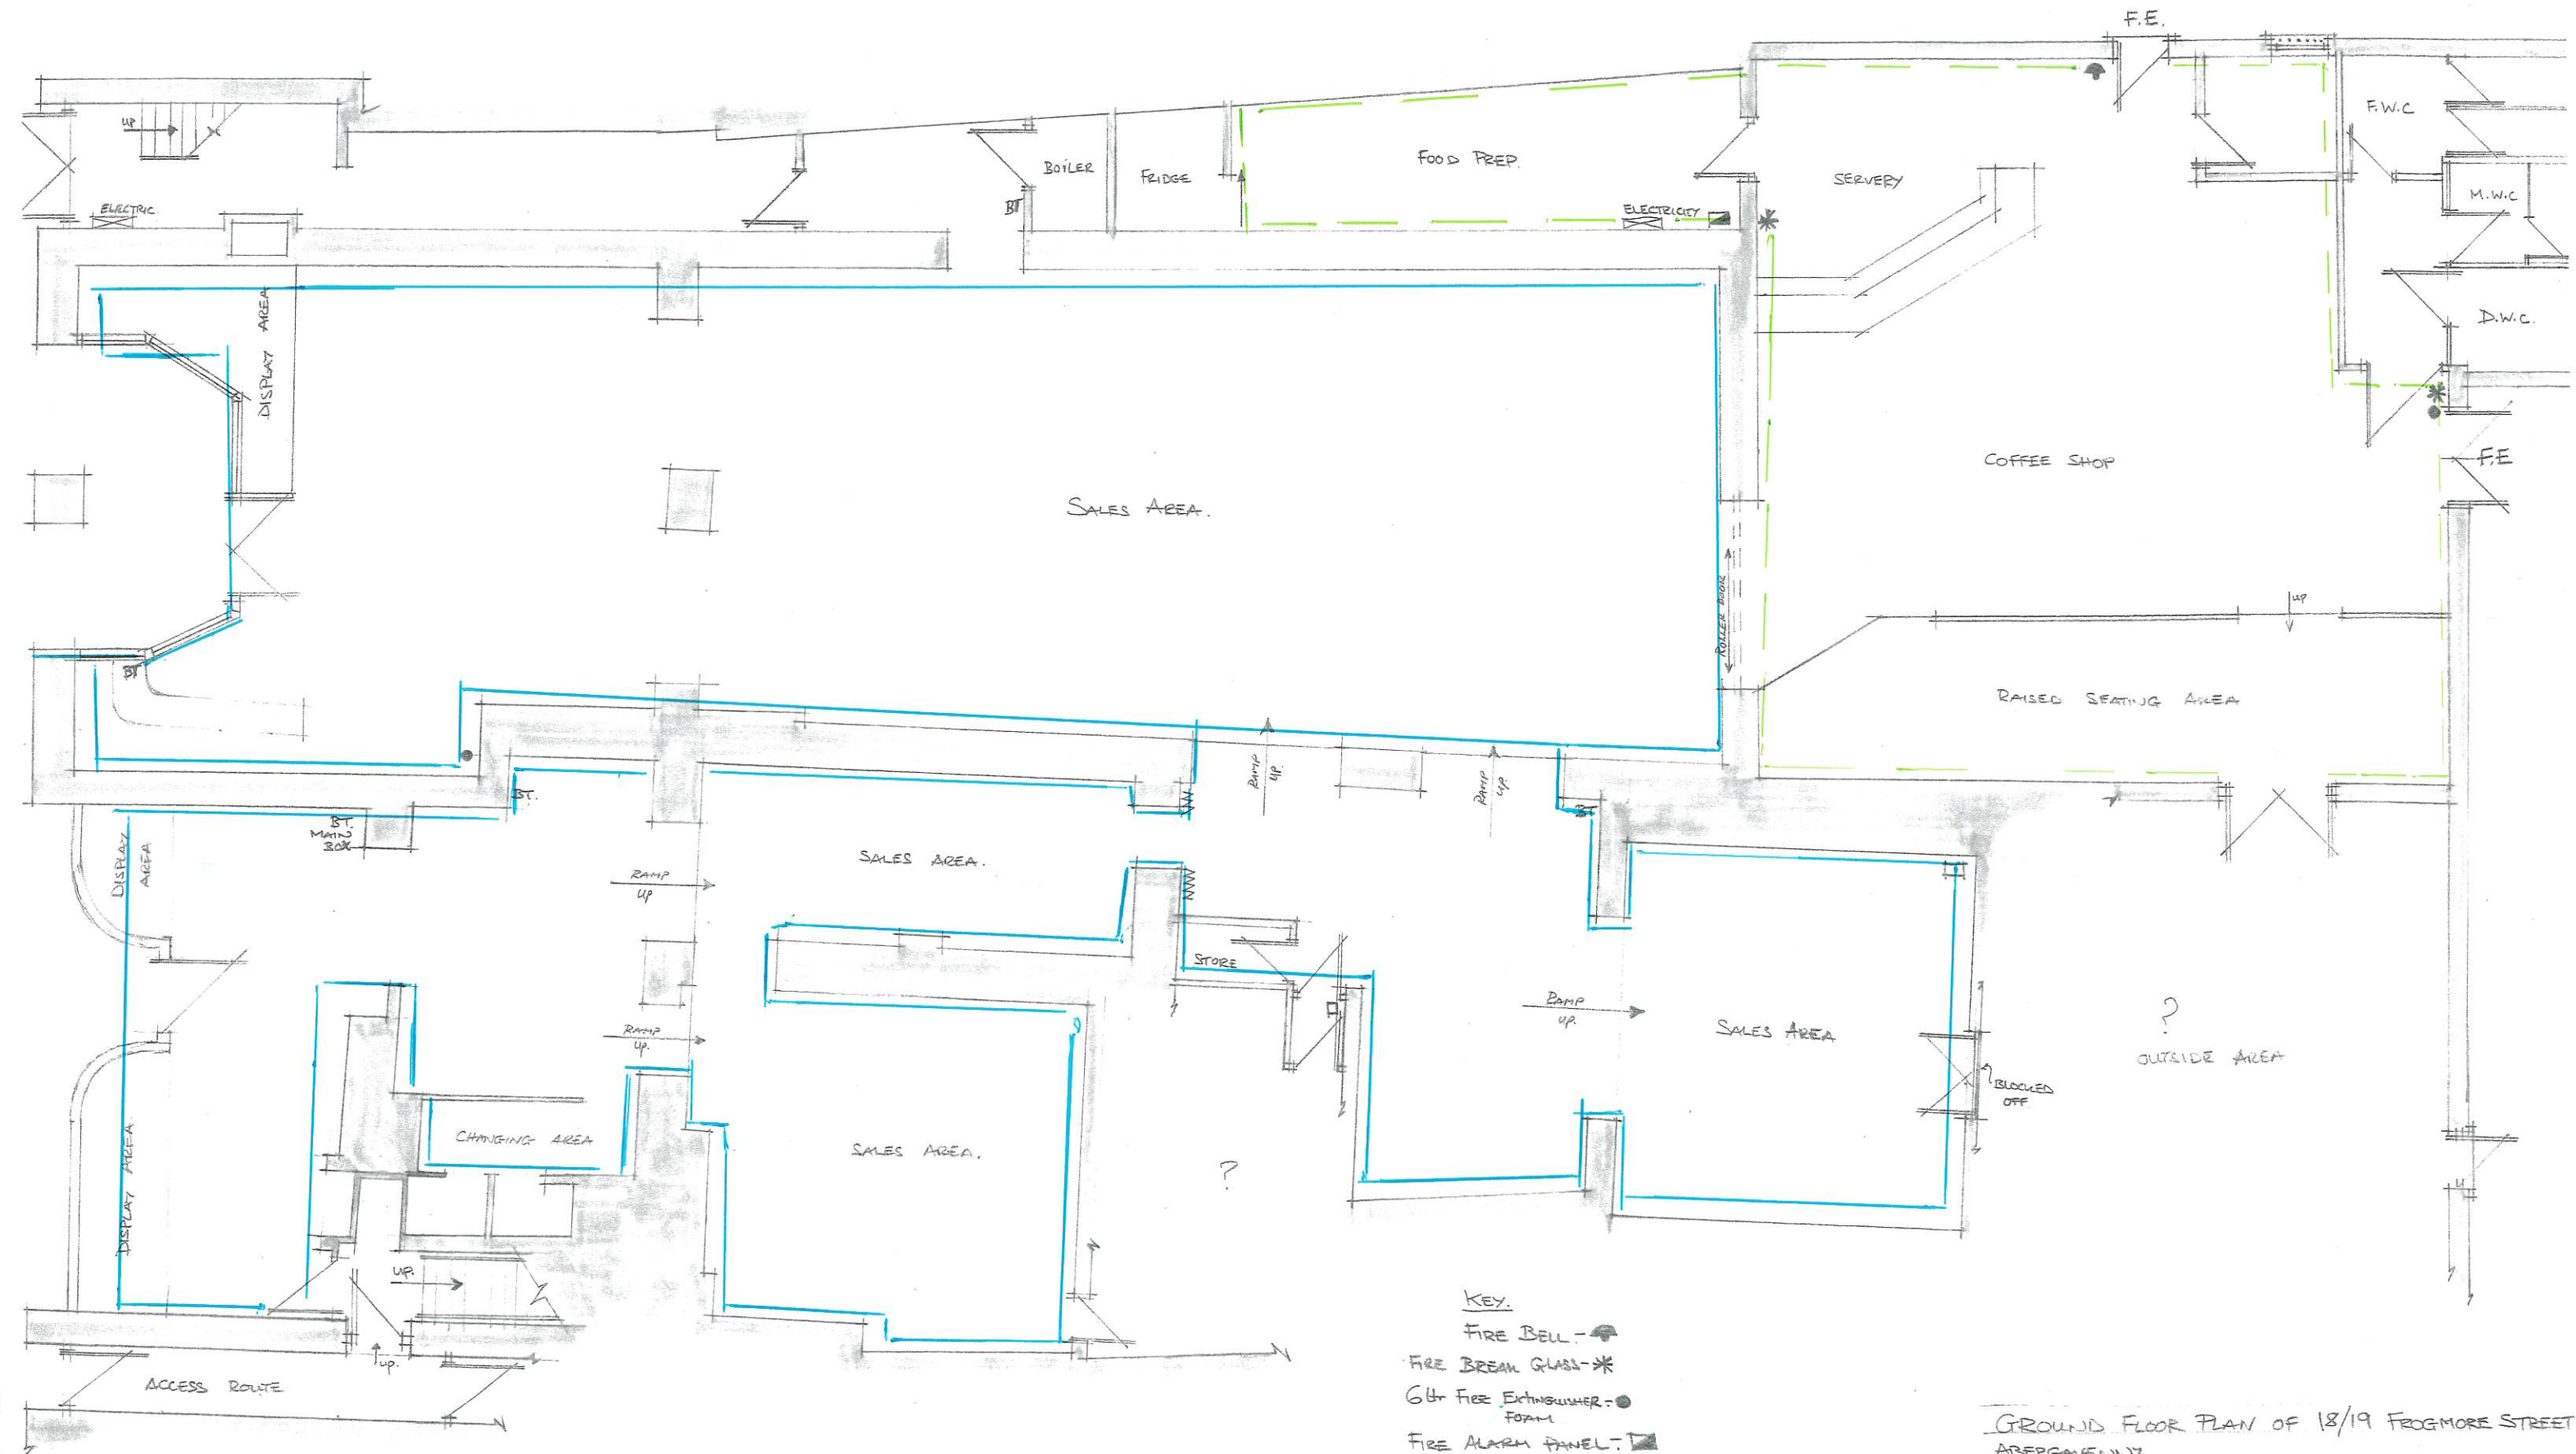

- KEY.
- FIRE BELL - [Symbol]
  - FIRE BREAK GLASS - [Symbol]
  - 6lt Fire Extinguisher - [Symbol]
  - FOAM
  - FIRE ALARM PANEL - [Symbol]
  - ELECTRICITY SUPPLY - [Symbol]
  - FUSE BOX - [Symbol]
  - PHONE POINT - BT
  - SEWER DRAIN - [Symbol]

GROUND FLOOR PLAN OF 18/19 FROGMORE STREET  
 ABERGAVENNY.  
 SCALE 1:100 Approx. SKETCH