



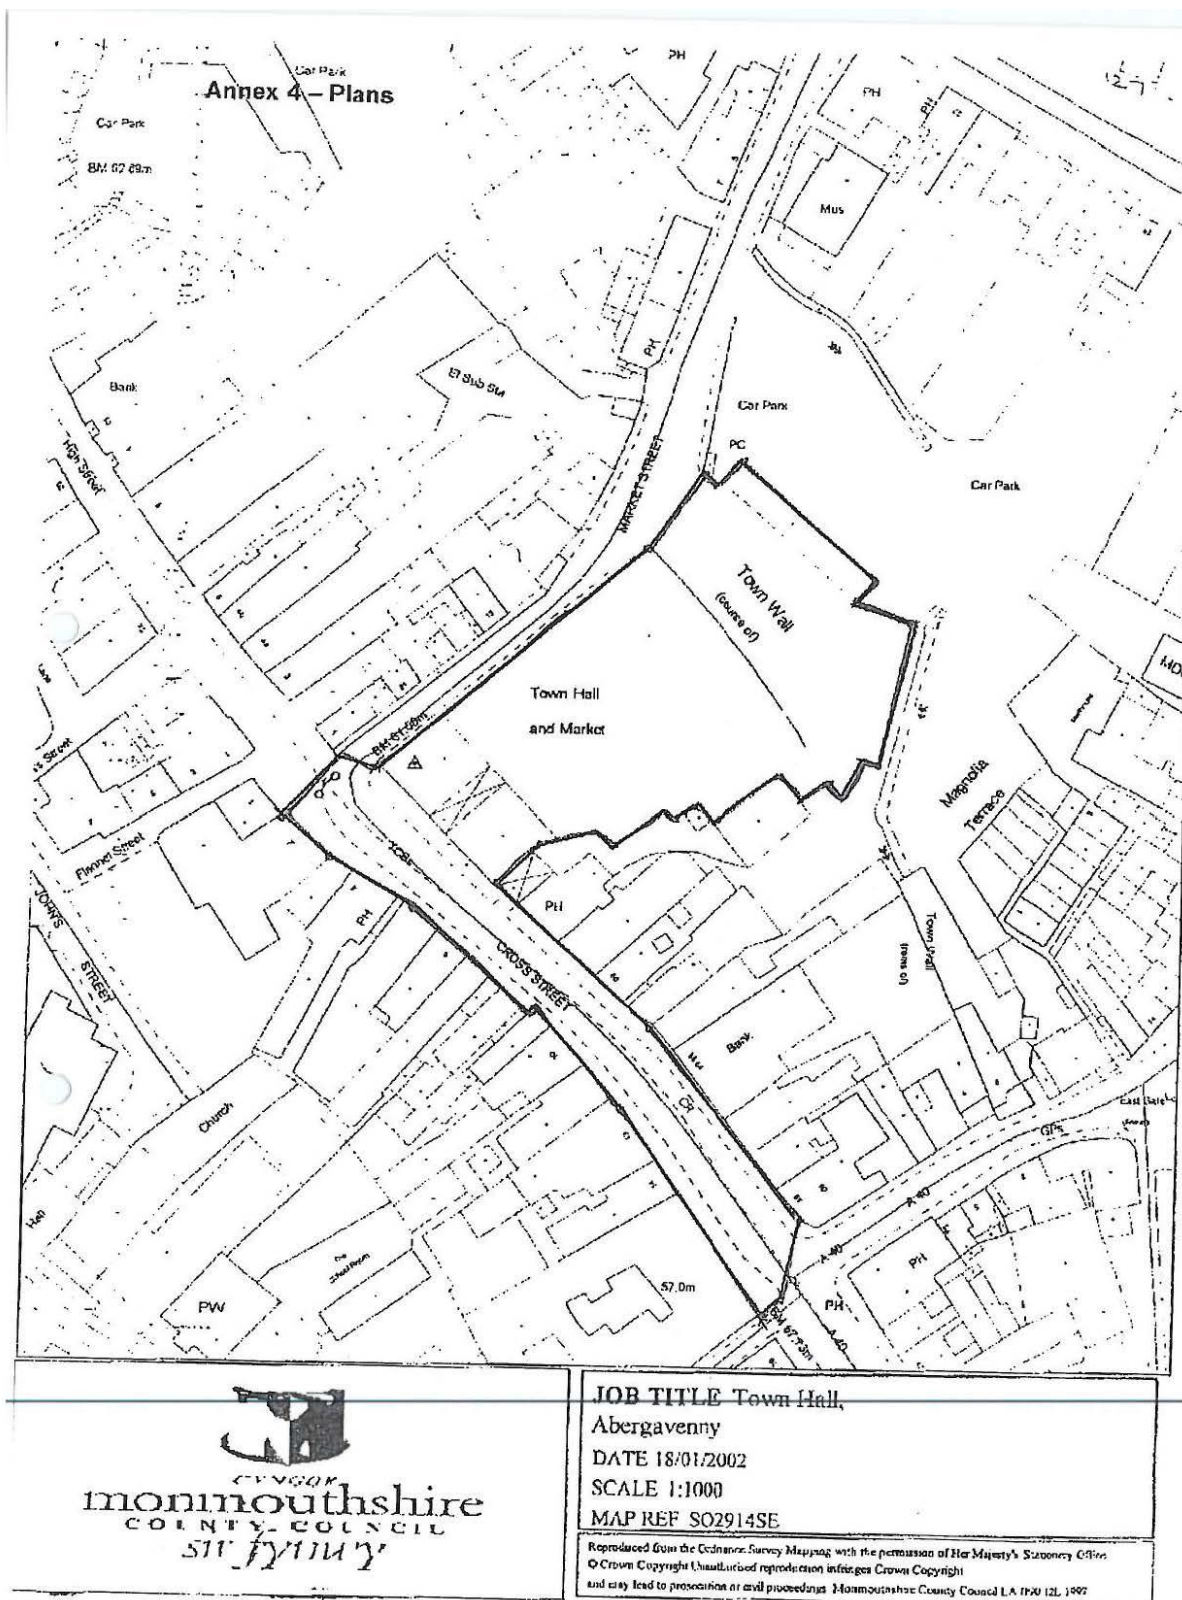

1/AH ACCESS LUGGERS  
C.P. CONTROL POINT  
A.S. ALARM SOUNDER

SS SMOKE DETECTOR  
F.E. A.F.B. EXTINGUISHER  
MURRY YARD

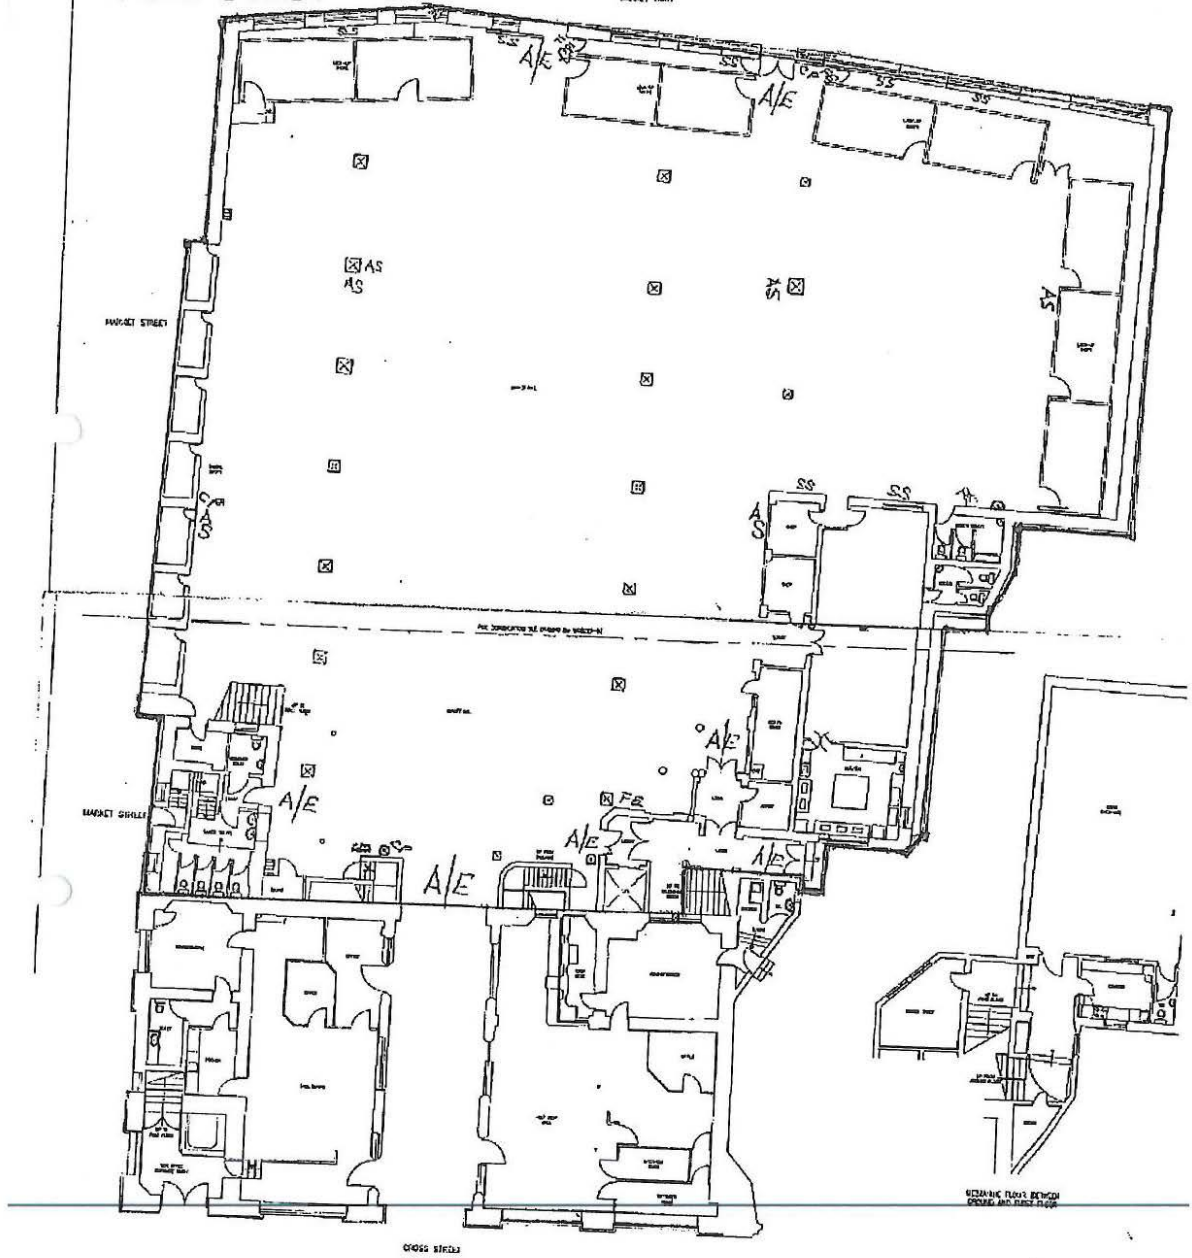


Site: Abergavenny Town Hall  
Existing layout: Ground Floor (Part)

Drawn: J.M.  
Checked: J.M.  
Approved: J.M.  
Date: 10/10/10

Scale: 1:100

Project: Abergavenny Town Hall  
Drawing No: 10/10/10  
Date: 10/10/10

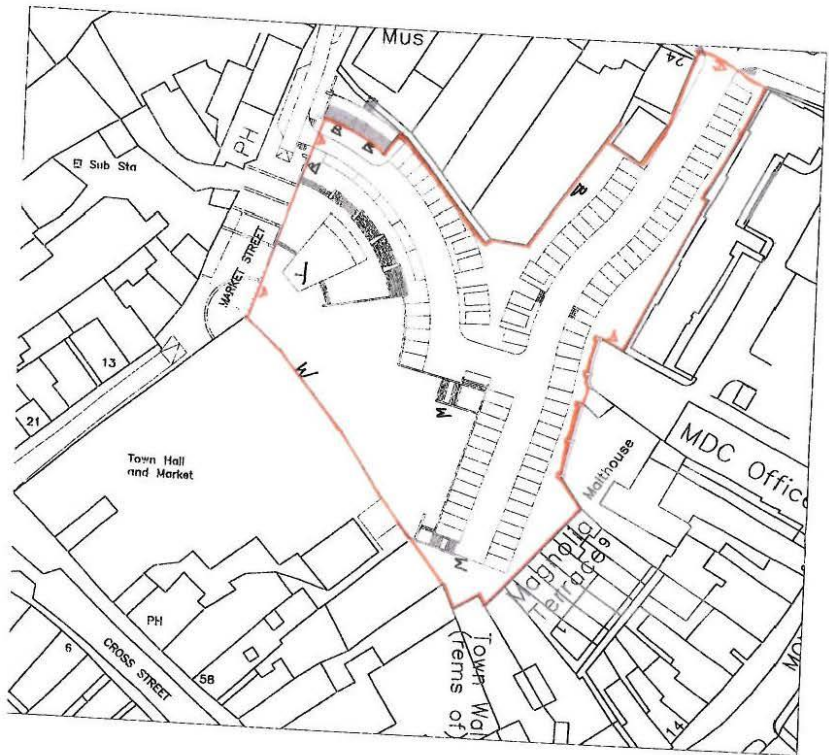

A - Access Easement  
 B - Fixed Bench  
 W - Waste Bin  
 T - Public Toilets

Site: Abergavenny Town Hall  
 Existing layout: Ground Floor (Part)

Scale: 1:500  
 Drawing No: 101/10  
 Date: 10/10/10  
 Drawn by: J. Jones  
 Checked by: J. Jones

Notes:  
 1. All dimensions are in metres.  
 2. All areas are in square metres.


Legend:  
 - Stairs  
 - Lift  
 - Entrance  
 - Exit  
 - Room


GROUND FLOOR  
 BETWEEN GROUND & 1<sup>st</sup> FLOOR: CORN. EXCHANGE AND KITCHEN  
 1<sup>st</sup> FLOOR: COUNCIL OFFICES  
 BETWEEN 1<sup>st</sup> FLOOR & 2<sup>nd</sup> FLOOR: DRESSING ROOM 2  
 2<sup>nd</sup> FLOOR: STAGE, AUDITORIUM STALLS, DRESSING ROOM 1  
 3<sup>rd</sup> FLOOR: BALCONY, CONTROL ROOM, TECHNICAL OFFICE

# Annex 4 - Plans

MAIN ENTRANCE TO THEATRE

CROSS STREET

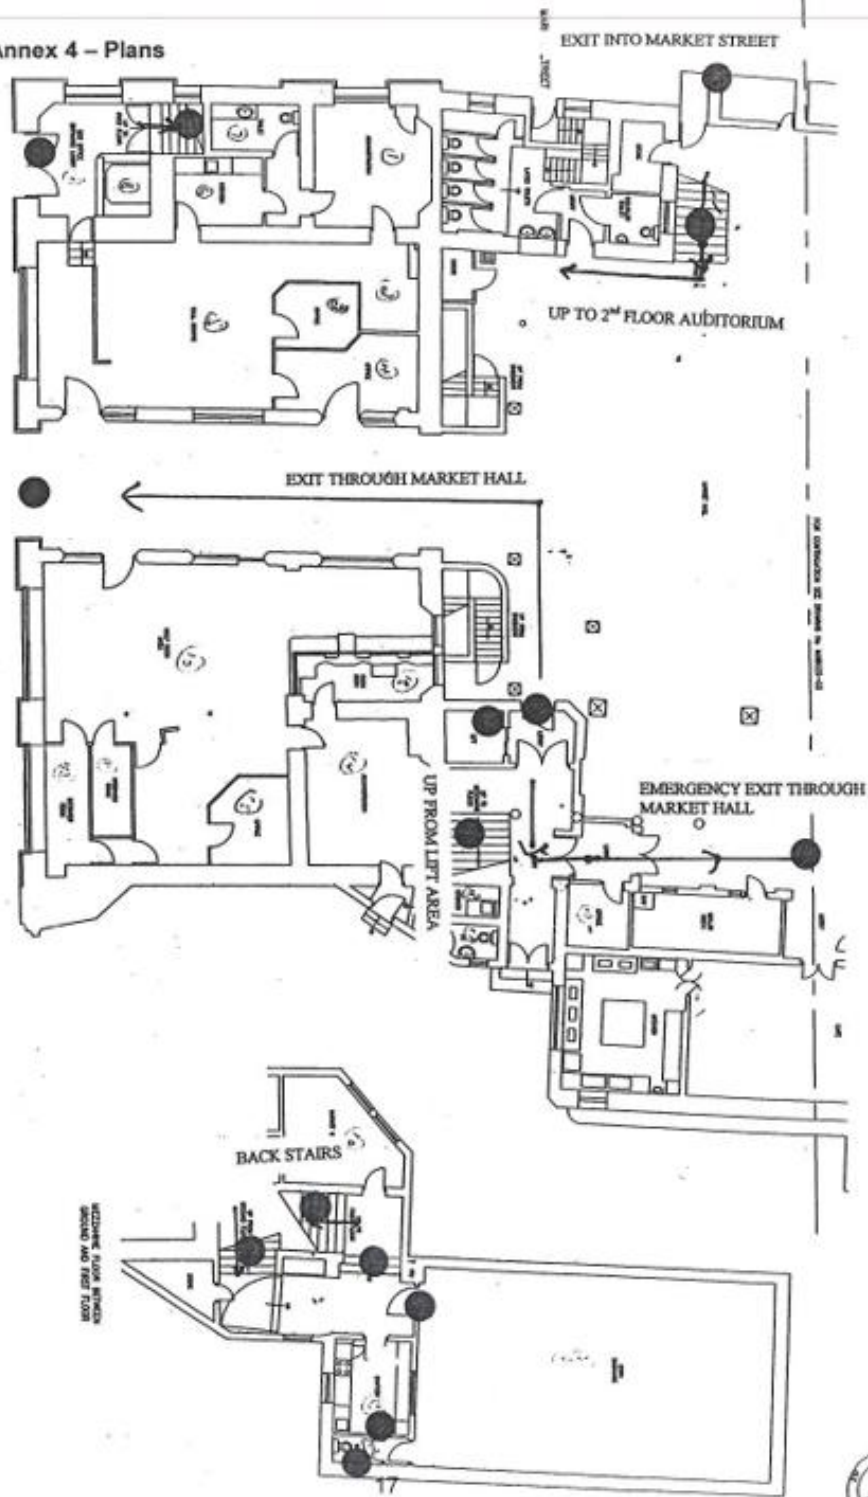

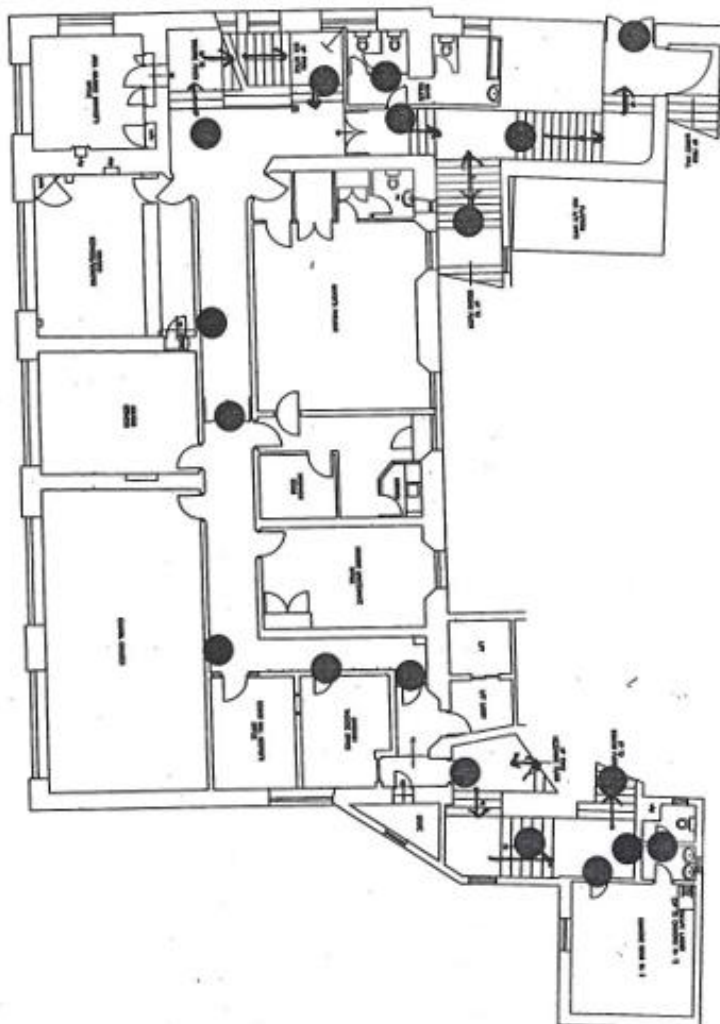


to: Aberystwyth Town Hall

Scale: 1:100  
Drawing No: 001/14/01  
Project Name: Old Town Hall





THIRD FLOOR PLAN

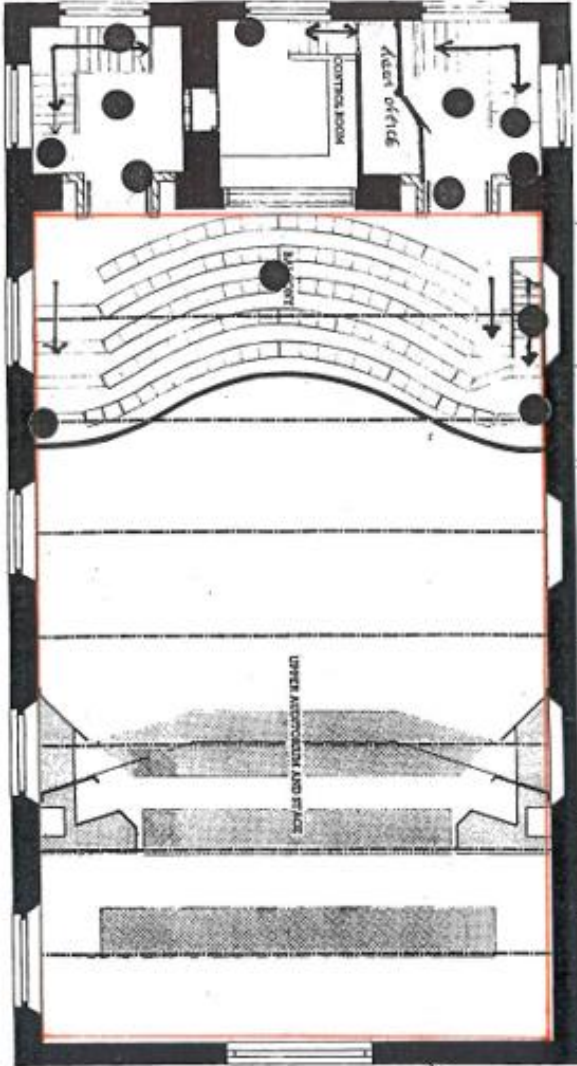


- KEY
- RED FIRE EXTINGUISHERS
  - GREEN ACCESS & EXITS
  - BLUE ALCOHOL
  - YELLOW KITCHEN
  - ORANGE TOILETS
  - ARROWS DIRECTION

DESIGN AVAILABLE FOR THE  
RENTAL OF THE ENTIRE BUILDING  
FOR ANY COMMERCIAL PURPOSES  
BY A.C.T. CONSULTANT SERVICES  
LIMITED  
11, GLEBE ROAD, GLEBE, N.S.W. 1530  
TEL: 02 9550 1111  
FAX: 02 9550 1112  
WWW.ACT-NSW.COM.AU

**A.C.T.**  
ARCHITECTS  
CONSULTANTS  
TRUSTEES

THIRD FLOOR PLAN

DRAWING NO. 100  
SCALE 1:50  
DATE 13/01/00

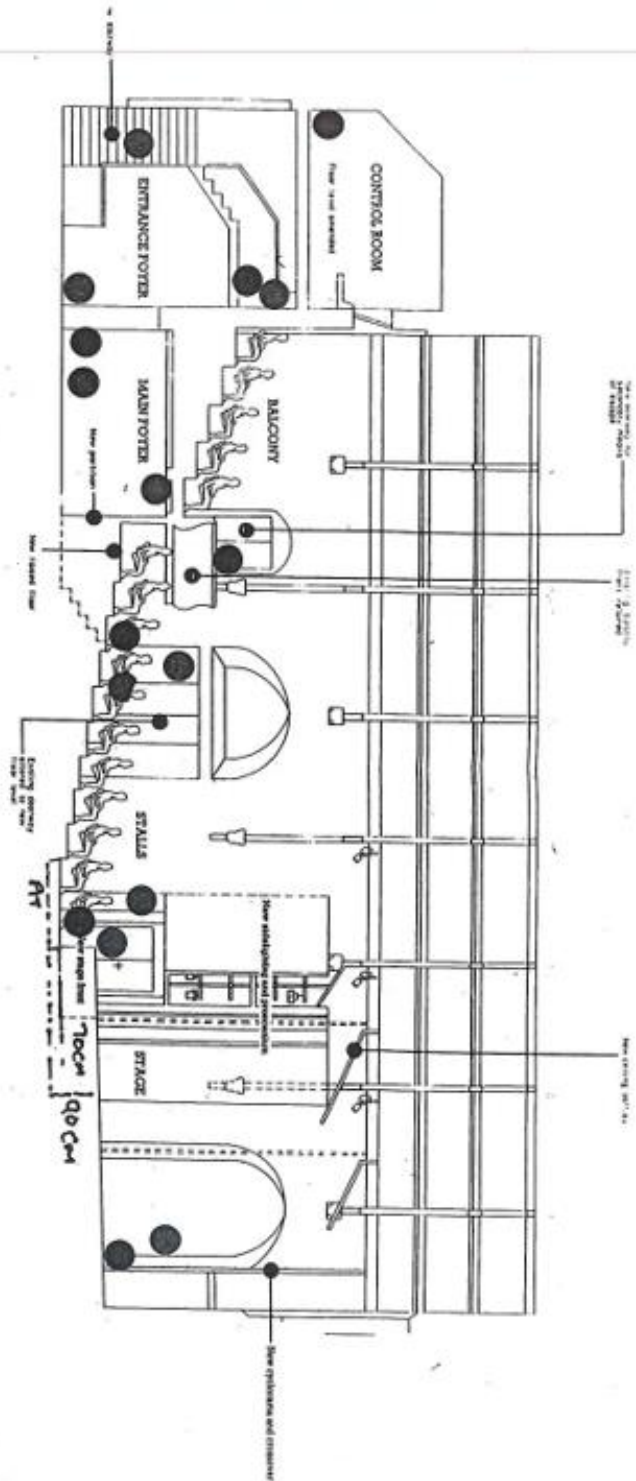

SECTION THROUGH THEATRE

DESIGN PROPOSALS FOR THE  
RENOVATION OF THE THEATRE  
BUILDING IN  
MONTREAL  
BY ACT CONSULTANT SERVICES  
ARCHITECTS  
UNIVERSITY OF MONTREAL  
OCTOBER 2011

**ACT**  
ARCHITECTS  
CONSULTANT SERVICES  
UNIVERSITY OF MONTREAL  
OCTOBER 2011

DESIGNED BY ACT  
ARCHITECTS  
CONSULTANT SERVICES  
UNIVERSITY OF MONTREAL  
OCTOBER 2011